


ARCHITECT/DESIGNER KATE SCHNEIDER, PAGE SUITE SUITE 500 00 W CESAR CHAVEZ AUSTIN, TX 78701 112-382-3552	PROJECT MANAGER CHRISTIAN GOURNAY, JLL SUITE 100 8343 DOUGLAS AVENUE DALLAS, TX 75225 214-236-7242
ELECTRICAL ENGINEER OSHUA GRIFFIN, PAGE SUITE SUITE 500 00 W CESAR CHAVEZ AUSTIN, TX 78701 112-382-3552	PLUMBING ENGINEER PAUL DIGIOVANNI, PAGE SUITE SUITE 500 1530 15TH ST DENVER, CO 80202 720-390-3016

DJO, LLC
DJO Corporate Renovation
LAKESIDE II OFFICE CENTER
2900 LAKE VISTA DRIVE
LEWISVILLE, TEXAS 75067

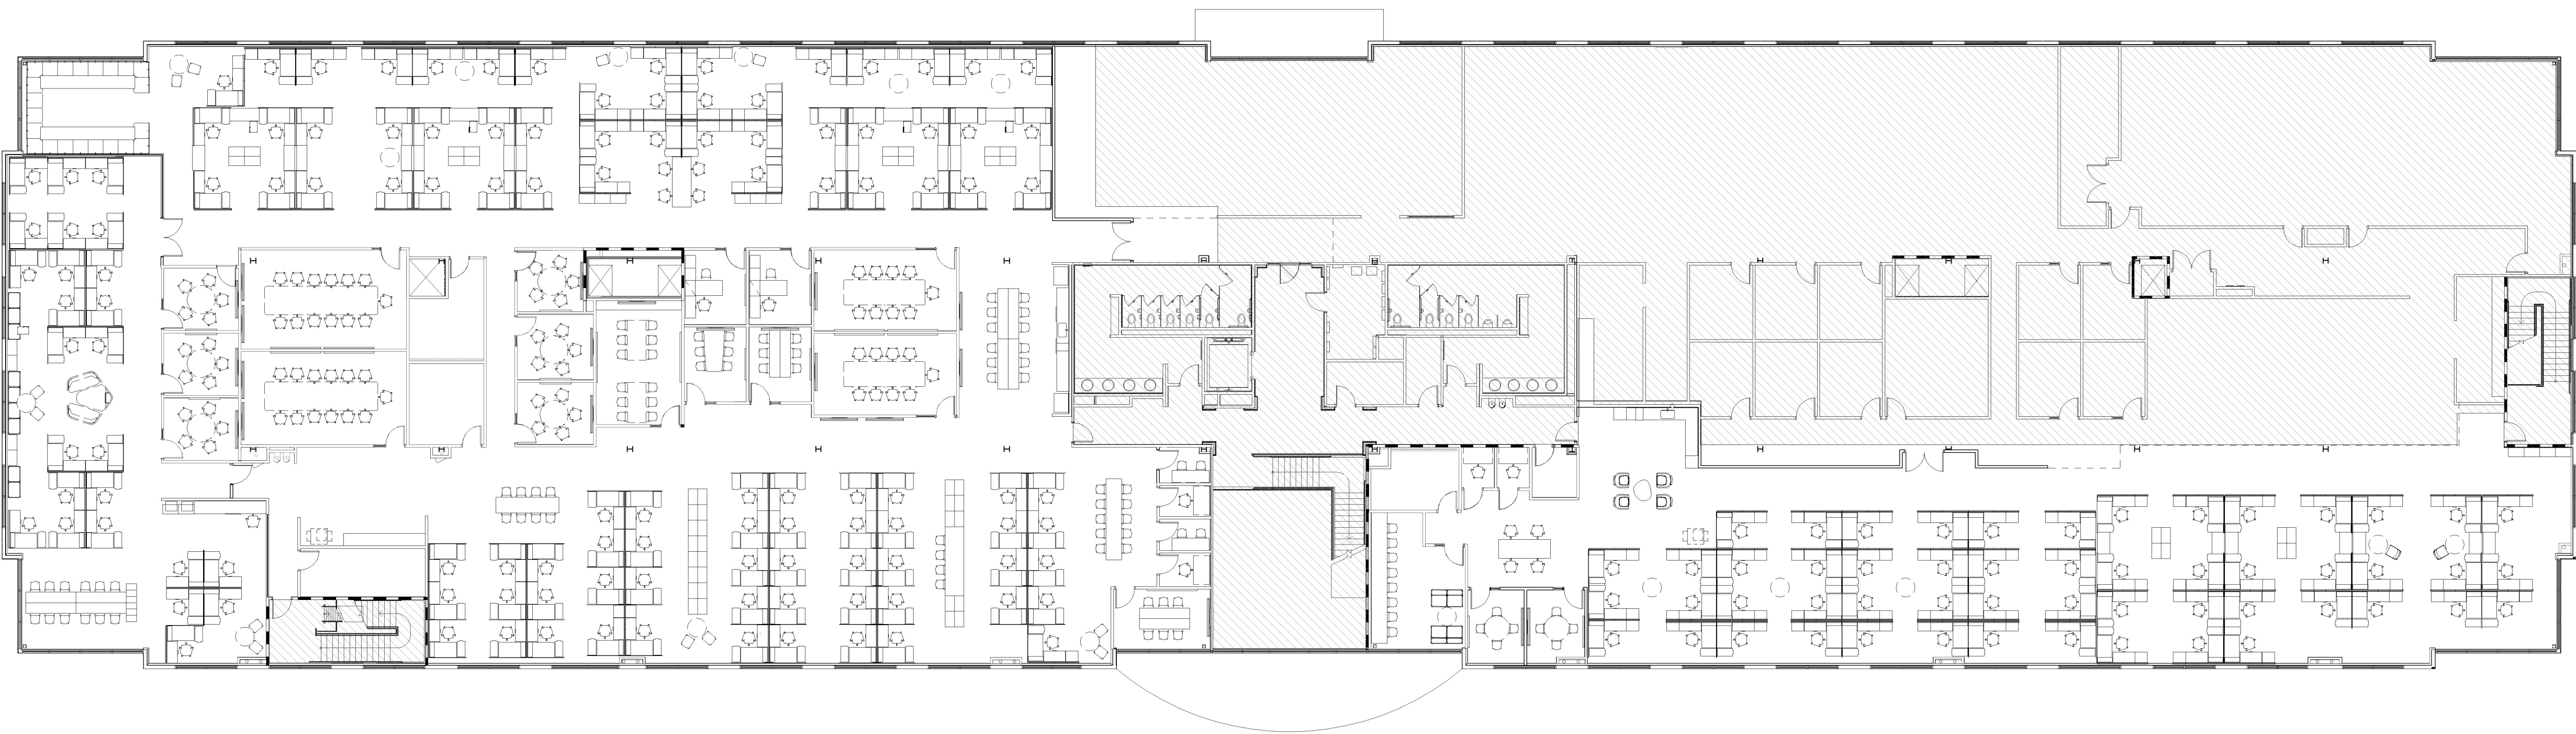


1 ARCHITECTURAL - OVERALL FLOOR PLAN - LEVEL 02
SCALE: 1/16" = 1'-0"


"Reviewed for Code Compliance"
By: [Signature]
Date Completed: 11/20/2018

PLANS TO REMAIN ON JOB-SITE

KEY PLAN (NOT TO SCALE)

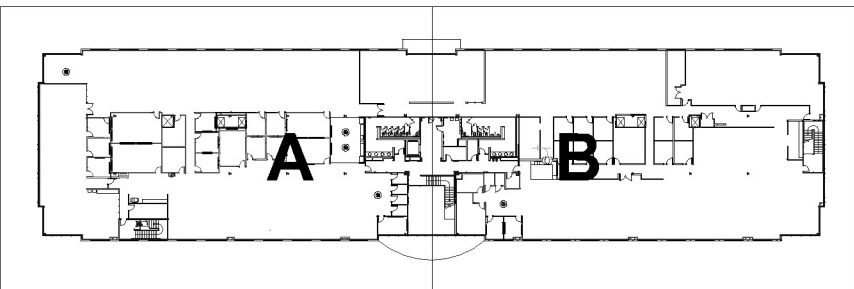

REVISION HISTORY

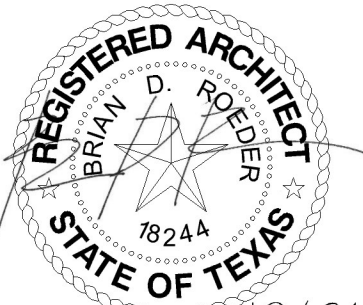

10/24/2018

ARCHITECTURAL - FLOOR PLAN -
LEVEL 02

DRAWN BY KS	CHECKED BY B
PROJECT NUMBER 118055	PROJECT ABBREVIATION DJCR
ORIGINAL ISSUE	DATE
ISSUE FOR CONSTRUCTION	10/24/201

A-101

SHEET NUMBER